


**ELECTRIC SYMBOL LEGEND**

- |   |                                       |                        |              |
|---|---------------------------------------|------------------------|--------------|
| ⊕ 115 V. DUPLEX APPLIANCE                           | ⊕ RECESS INCANDESCENT                 | ⊕ SPECIAL OUTLET       | ⊕ CHIME      |
| ⊕ W.P. (GFI) 115 V. DUPLEX WEATHER-PROOF OUTLET GFI | ⊕ MOTOR                               | ⊕ PHONE JACK           | ⊕ INTERCOM   |
| ⊕ GFI 115 V. DUPLEX OUTLET GFI                      | ⊕ EXHAUST FAN                         | ⊕ CABLE T.V. JACK      | ⊕ SPEAKER    |
| ⊕ AFL 115 V. DUPLEX OUTLET AFL                      | ⊕ 2-WAY FLOOD                         | ⊕ SINGLE POLE SWITCH   | ⊕ METER      |
| ⊕ 115 V. DUPLEX OUTLET CEILING AFL CLG (AFL)        | ⊕ 4'2 TUBE FLOURESCENT                | ⊕ 3-WAY SWITCH         | ⊕ DISCONNECT |
| ⊕ AFL 115 V. DUPLEX OUTLET FLOOR AFL                | ⊕ 8'2 TUBE FLOURESCENT                | ⊕ DIMMER SWITCH        | ⊕ PANEL      |
| ⊕ 230 V. OUTLET                                     | ⊕ SD SMOKE & CARBON MONOXIDE DETECTOR | ⊕ CEILING INCANDESCENT |              |
| ⊕ JUNCTION BOX                                      | ⊕ PUSH BUTTON                         | ⊕ WALL INCANDESCENT    | ⊕ EXIT LIGHT |

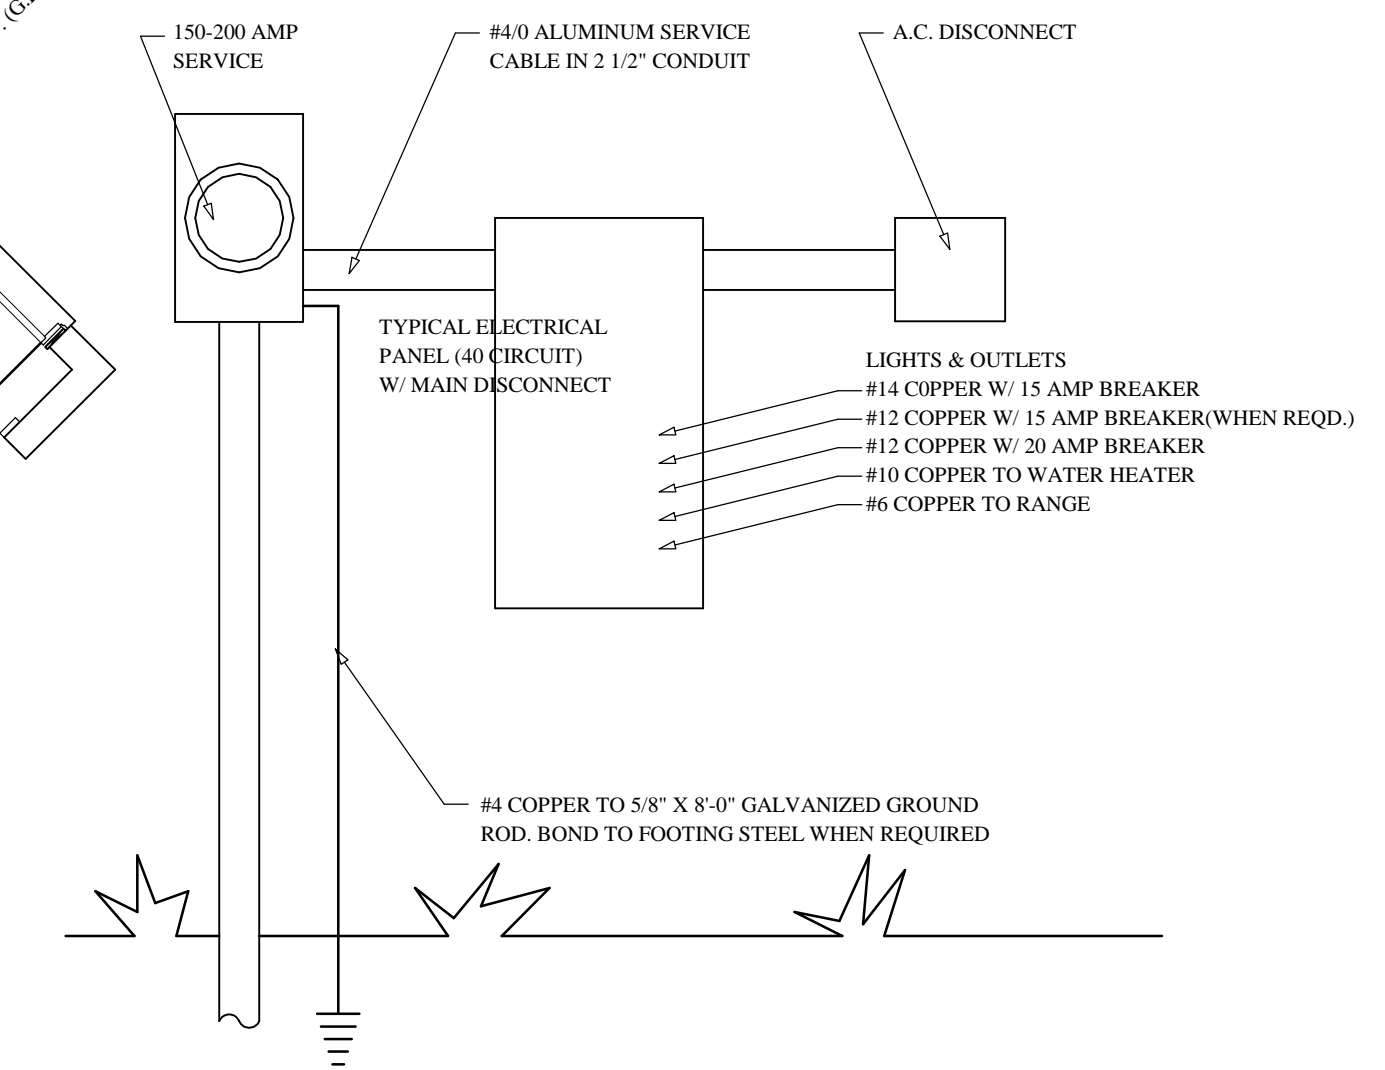

**ELECTRICAL RISER DIAGRAM**

ALL 125V OUTLETS IN LIVING AREAS SHALL BE ARC FAULT PER NEC 210.12(B)  
 SMOKE DETECTORS AND CARBON MONOXIDE ALARMS TO BE PROVIDED AS PER FBCE 314 & 315  
 ELECTRICAL MATERIALS AND INSTALLATIONS SHALL COMPLY WITH ALL APPLICABLE PROVISIONS OF THE NATIONAL, STATE, LOCAL AND POWER ELECTRICAL CODES.

**ELECTRIC PLAN**

Scale 1/4" = 1'-0"

REVISIONS	

NEW CONCRETE BLOCK HOUSE FOR  
**KENT CUSTOM HOMES, INC.**  
 OSCEOLA COUNTY, FLORIDA  
 JON HOKE, 2718 TROPICAL LAKE DR., KISSIMMEE, FL. 34741  
 PHONE 1-407-738-5873

DRAWN BY JON HOKE
CHECKED BY M.S.
DRAWING NUMBER 13-012-2
DATE 6/1/2013
SHEET <b>6</b>
OF 6 SHEETS