


ELECTRIC PLAN

Scale 1/4" = 1'-0"

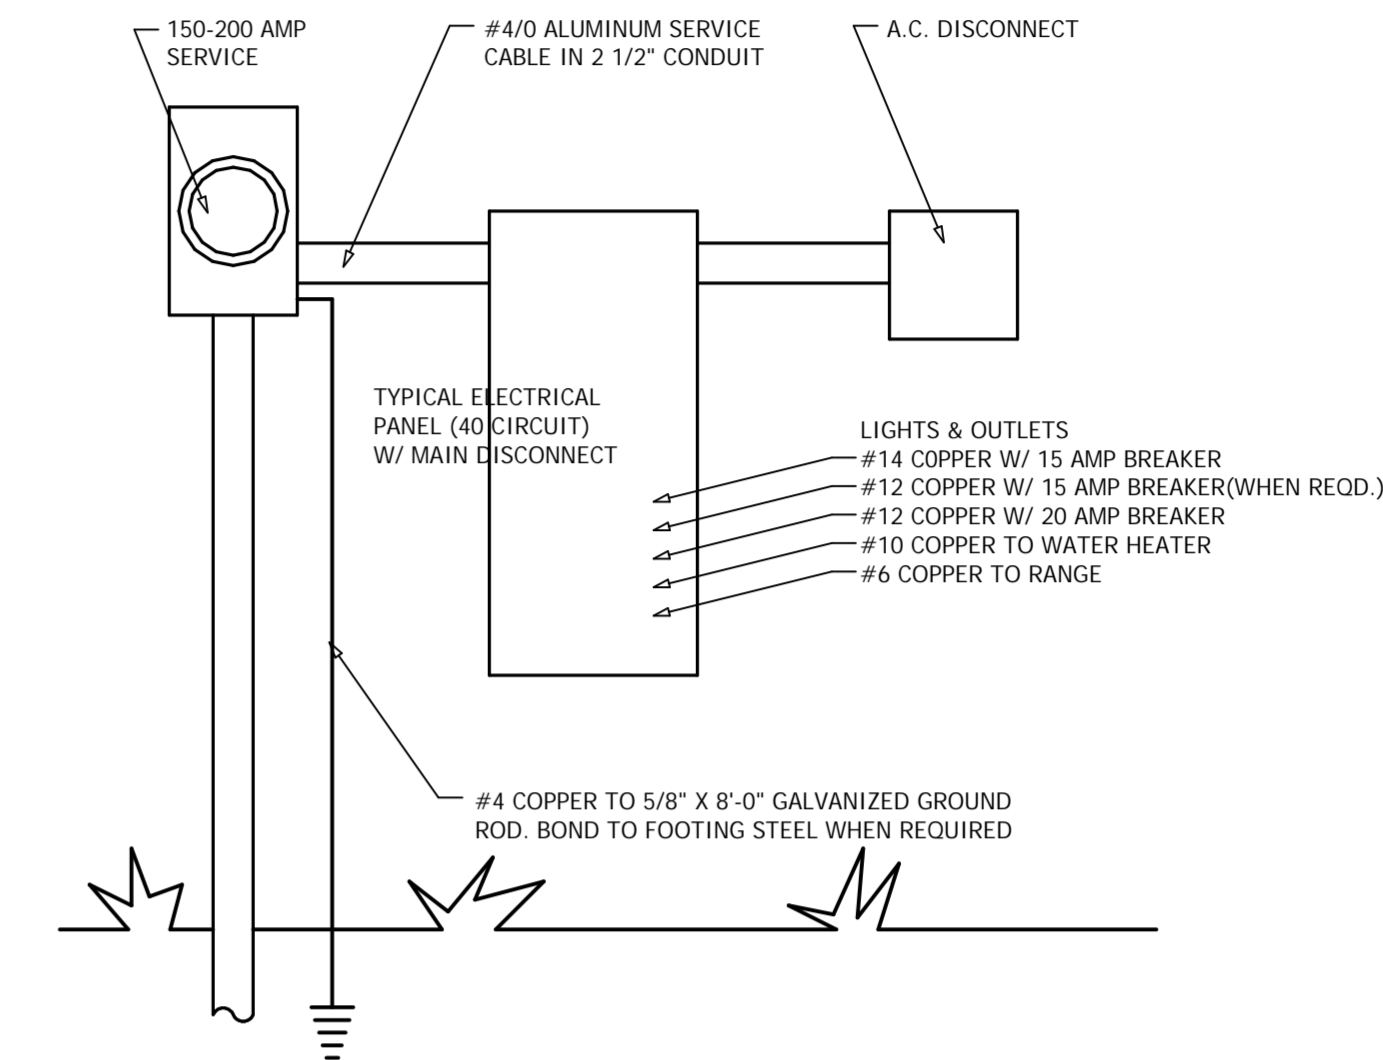

ELECTRICAL RISER DIAGRAM

ALL OUTLETS IN SLEEPING ROOMS SHALL BE ARC FAULT
 SMOKE DETECTORS SHALL BE IN ALL SLEEPING AREAS, SHALL BE INTERCONNECTED, SHALL BE WITHIN 1'-0" TO 3'-0" OF PEAK AND SHALL BE WITHIN 3'-0" OF ANY SUPPLY OR RETURN AIR STREAM AND EQUIPPED WITH A BATTERY BACK-UP.
 ELECTRICAL MATERIALS AND INSTALLATIONS SHALL COMPLY WITH ALL APPLICABLE PROVISIONS OF THE NATIONAL, STATE, LOCAL AND POWER ELECTRICAL CODES.

ELECTRIC SYMBOL LEGEND

⊕	115 V. DUPLEX OUTLET	□	RECESS INCANDESCENT	⊕	SPECIAL OUTLET	⌋	CHIME
⊕ W.P.	115 V. DUPLEX WEATHER-PROOF OUTLET	⊕	MOTOR	⊕	PHONE JACK	⌋	INTERCOM
⊕ GFI	115 V. DUPLEX OUTLET GFI	⊕	EXHAUST FAN	⊕ TV	CABLE T.V. JACK	⌋	SPEAKER
⊕ AFI	115 V. DUPLEX OUTLET AFI	⊕	2-WAY FLOOD	⊕	SINGLE POLE SWITCH	⌋	METER
⊕ CLG	115 V. DUPLEX OUTLET CEILING	⊕	4'2" TUBE FLOURESCENT	⊕ 3	3-WAY SWITCH	⌋	DISCONNECT
⊕	115 V. DUPLEX OUTLET FLOOR	⊕	8'2" TUBE FLOURESCENT	⊕	DIMMER SWITCH	⌋	PANEL
⊕	230 V. OUTLET	⊕ SD	SMOKE DETECTOR	⊕	CEILING INCANDESCENT		
⊕	JUNCTION BOX	⊕	PUSH BUTTON	⊕	WALL INCANDESCENT		

NEW CONCRETE BLOCK RESIDENCE FOR
KENT CUSTOM HOMES, INC.
 FOR EDWARDS, OSCEOLA COUNTY, FLORIDA
 JON HOKE, 2718 TROPICAL LAKE DR., KISSIMEE, FL. 34741
 PHONE 1-407-847-7742

DRAWN BY
 JON HOKE
 CHECKED BY
 M.S.
 DRAWING NUMBER
 04-021
 DATE
 5/29/2004
5
 OF 5 SHEETS